


GENERAL NOTES:

1. ANTI-FLOOD CONTROL PANEL TO BE LOCATED ON WALL OR UNISTRUT SUPPORT SYSTEM. ALLOW 36" CLEAR SPACE IN FRONT OF PANEL.
2. INSTALLATION AND MAINTENANCE MANUAL TO BE LOCATED IN POCKET ON INSIDE OF CONTROL PANEL DOOR.

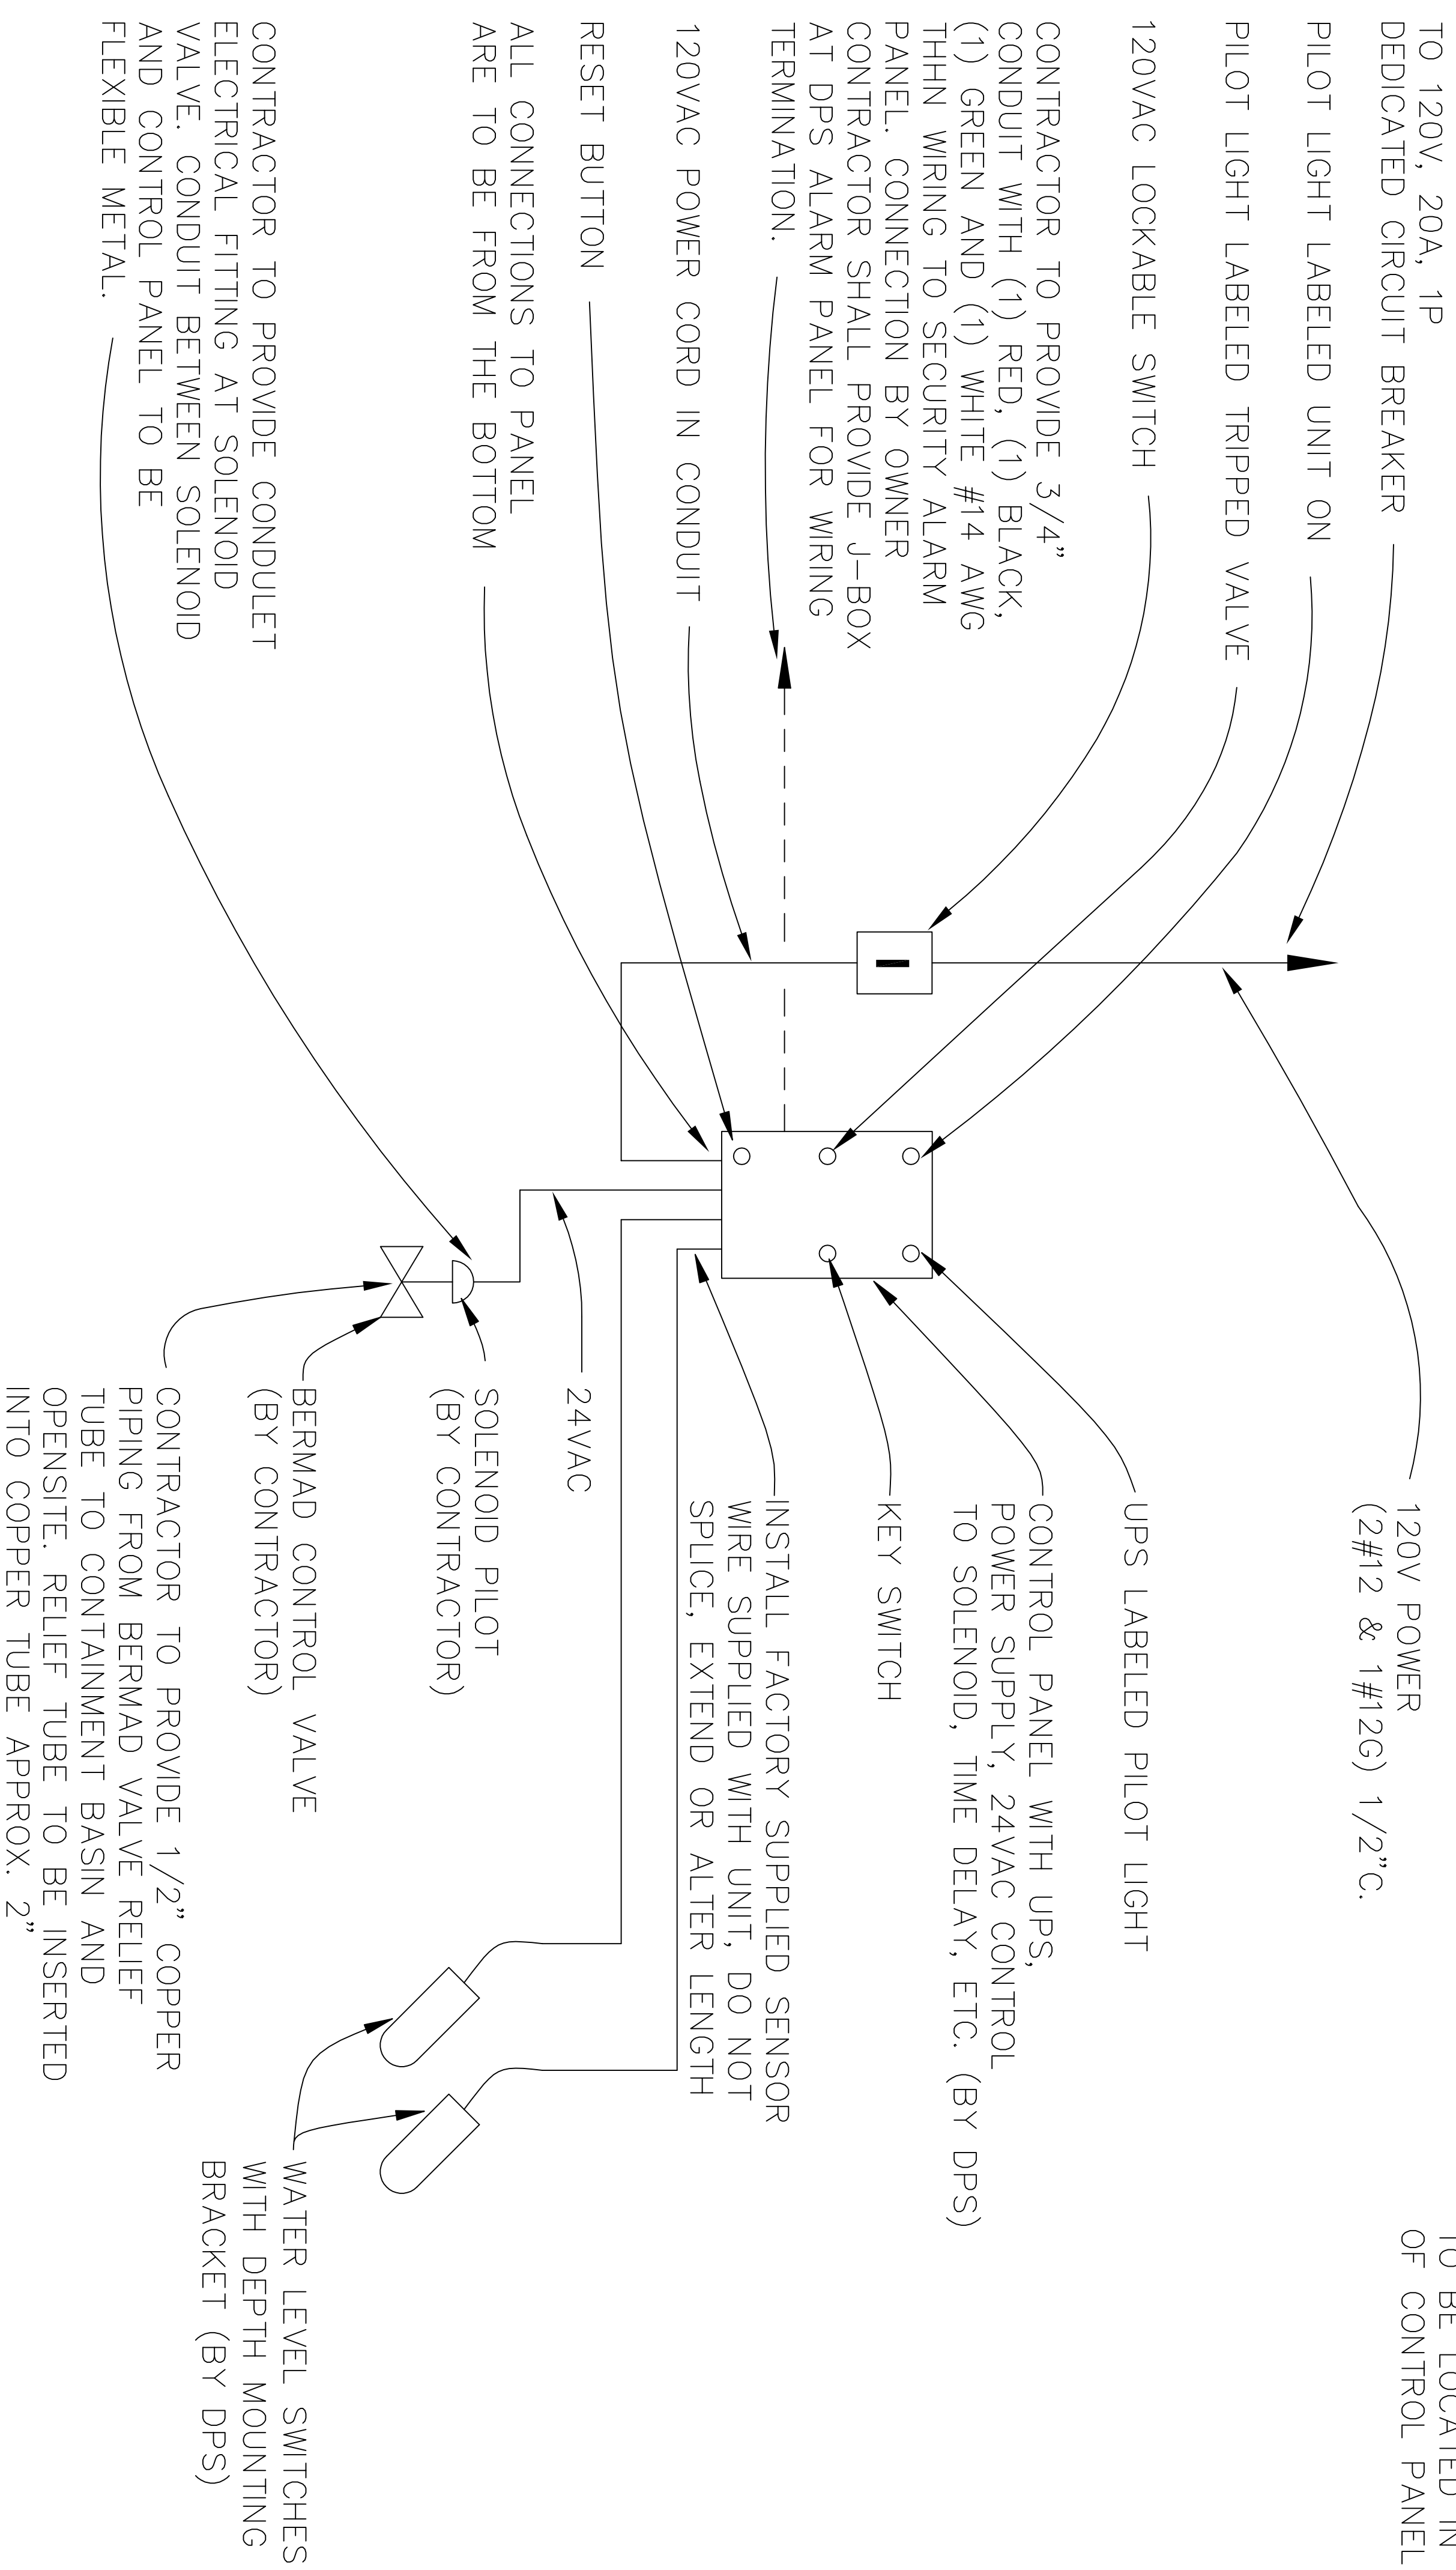

ANTI-FLOOD SYSTEM
CONTROL DIAGRAM
NOT TO SCALE

<p>DENVER PUBLIC SCHOOLS DEPARTMENT OF FACILITIES MANAGEMENT</p>		<p>DWG. NO. 15431-P1</p>	
<p>DRAWN: DPS</p>	<p>BACKFLOW PREVENTER STANDARDS</p>	REV.	0
<p>CHECKED: DPS</p>	<p>ANTI-FLOOD SYSTEM</p>	SHEET:	1
<p>APPROVED: DPS</p>	<p>CONTROL DIAGRAM</p>	OF:	12
<p>DATE: 11/20/03</p>			
<p>SCALE: NONE</p>			